



Republic of the Philippines
Department of Education
Cordillera Administrative Region

BID BULLETIN NO. 1

TO : All interested Bidders
All Concerned

FROM : **ATTY. SEBASTIAN G. TAYABAN**
BAC Co-Chairperson

PROJECT : ***Repair/ Rehabilitation of Office, stage and covered court of
the DepEd-CAR Regional Office***

DATE : December 16, 2021

Project Identification Number CB 2021-028.


1. For the information of all interested bidders and all concerned is a change in **15. Bid Security** of the bidding documents:

FROM	TO
15.1. The Bid and bid security shall be valid until April 26, 2021. Any bid not accompanied by an acceptable bid security shall be rejected by the Procuring Entity as non-responsive.	15.1. The Bid and bid security shall be valid until April 26, 2022. Any bid not accompanied by an acceptable bid security shall be rejected by the Procuring Entity as non-responsive.


2. Attached is **Section VII. Drawings** of the Bidding Documents
3. This forms part of the bidding documents.



Section VII. Drawings

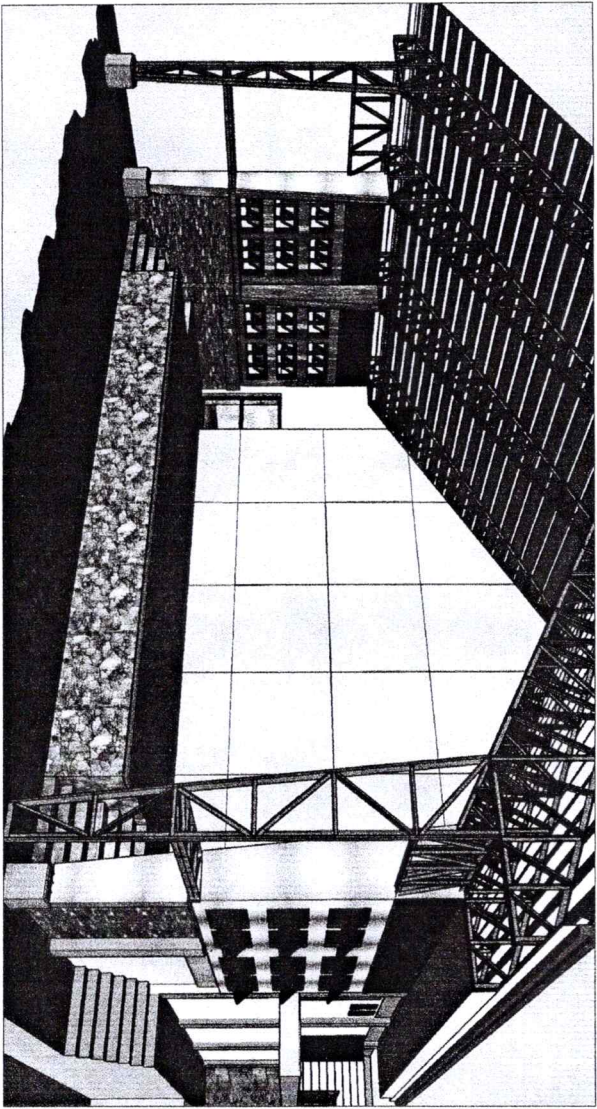

1
A 1
PERSPECTIVE
DRAWN NOT TO SCALE

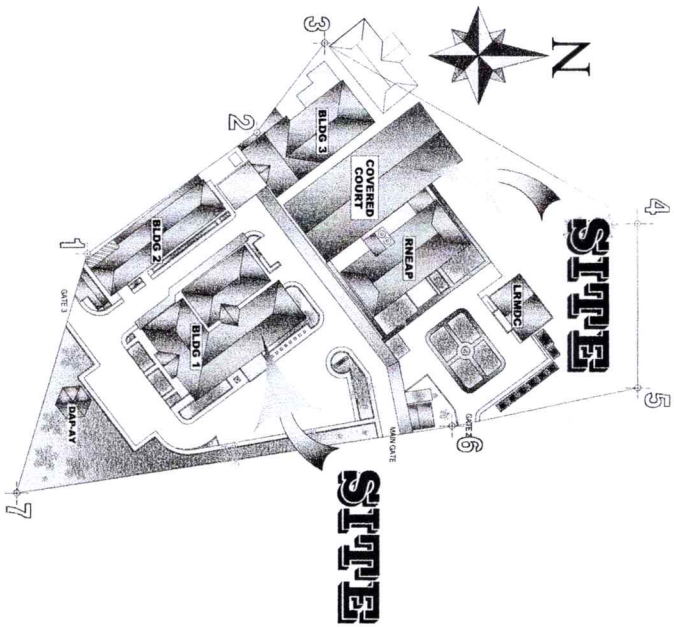

2
A 1
SITE DEVELOPMENT PLAN
DRAWN NOT TO SCALE

REPUBLIC OF THE PHILIPPINES DepEd EDUCATION FACILITIES SECTION WANGAL, LA TRINIDAD, BENGUET		PREPARED BY: CULLEN S. WEGYON DRAFTSMAN II <small>FEB 2021</small>	CHECKED AND REVIEWED: CHRISTOPHER B. HADSAN ENGINEER III	RECOMMENDING APPROVAL: EDGAR H. MADLANG CHIEF, ESSD	APPROVED BY: ESTELA L. CARINO REGIONAL DIRECTOR	PROJECT TITLE: REPAIR/REHABILITATION OF VARIOUS OFFICES AT THE DEPED-CAR REGIONAL OFFICE LOCATION: WANGAL, LA TRINIDAD, BENGUET SHEET CONTENT: AS SHOWN	SHEET NO.: A 1
---	--	---	--	---	---	---	-------------------

PREPARED BY: *[Signature]*
 CULLEN S. WEGITON
 DRAFTSMAN II
 Feb. 2021



CHECKED AND REVIEWED:
 CHRISTOPHER B. HADSAN
 ENGINEER III

RECOMMENDING APPROVAL:
 EDGAR H. MADLANG
 CHIEF, ESSD





APPROVED BY:
 ESTELA L. CARINO
 REGIONAL DIRECTOR

PROJECT TITLE:
 REPAIR/REHABILITATION OF VARIOUS OFFICES
 AT THE DEPED-CAR REGIONAL OFFICE
 LOCATION: WANGAL, LA TRINIDAD, BENGUET
 SHEET CONTENT: AS SHOWN

SHEET NO.:
 A 2
 2

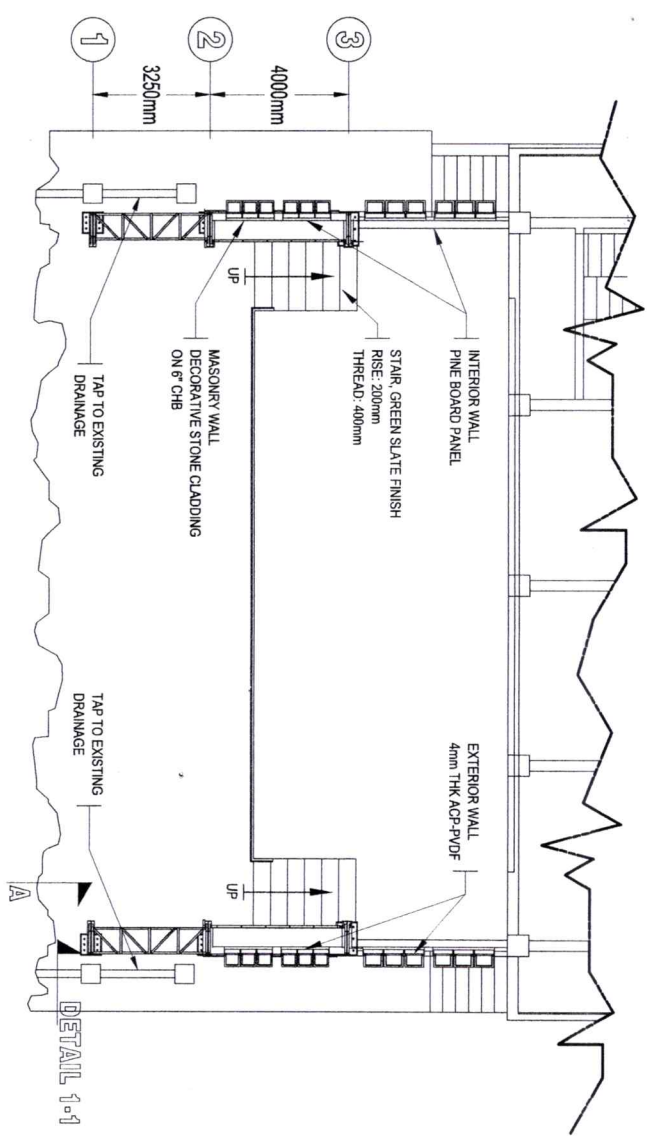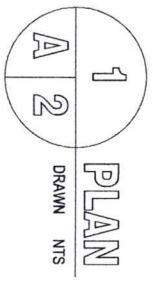

DETAIL 1-1

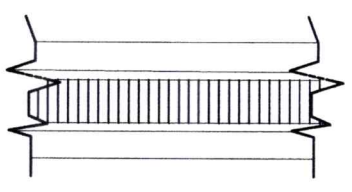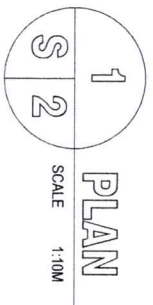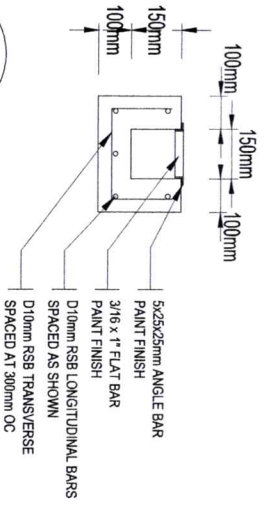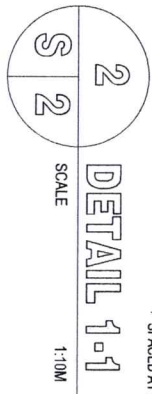

SCALE 1:10M

PREPARED BY:
 CULLEN S. WEGYON
 DRAFTSMAN II
 Feb 2021

CHECKED AND REVIEWED:
 CHRISTOPHER B. HADSAN
 ENGINEER III


RECOMMENDING APPROVAL:
 EDGAR H. MADLAING
 CHIEF, ESSD

APPROVED BY:
 ESTELA L. CARINO
 REGIONAL DIRECTOR

PROJECT TITLE:
 REPAIR/REHABILITATION OF VARIOUS OFFICES
 AT THE DEPED-CAR REGIONAL OFFICE
 LOCATION: WANGAL, LA TRINIDAD, BENGUET
 SHEET CONTINUED AS SHOWN

SHEET NO.:

- 4mm THK x 550x550mm ALUMINIUM COMPOSITE PANEL OUTER COVERING INCL. STIFFENER SOFFT AND TRUSS COLUMN ON 1.5x50x100 TUBULAR STUDS
- 600x H-1335mm ANALOK ALUMINIUM FRAMED AWNING WINDOW W/ 6.0mm THK BRONZE GLASS, COMPLETE WITH HARDWARES AND ACCESSORIES
- 600x H-1575mm ANALOK ALUMINIUM FRAMED AWNING WINDOW W/ 6.0mm THK BRONZE GLASS, COMPLETE WITH HARDWARES AND ACCESSORIES
- 4mm THK x 550x550mm ALUMINIUM COMPOSITE PANEL TRUSS COLUMN COVERING ON 1.5x50x50 TUBULAR STUDS
- DECORATIVE STONE WALL CLADDING FINISH ON BOTH FACE ON 150mm THK CHB WALL

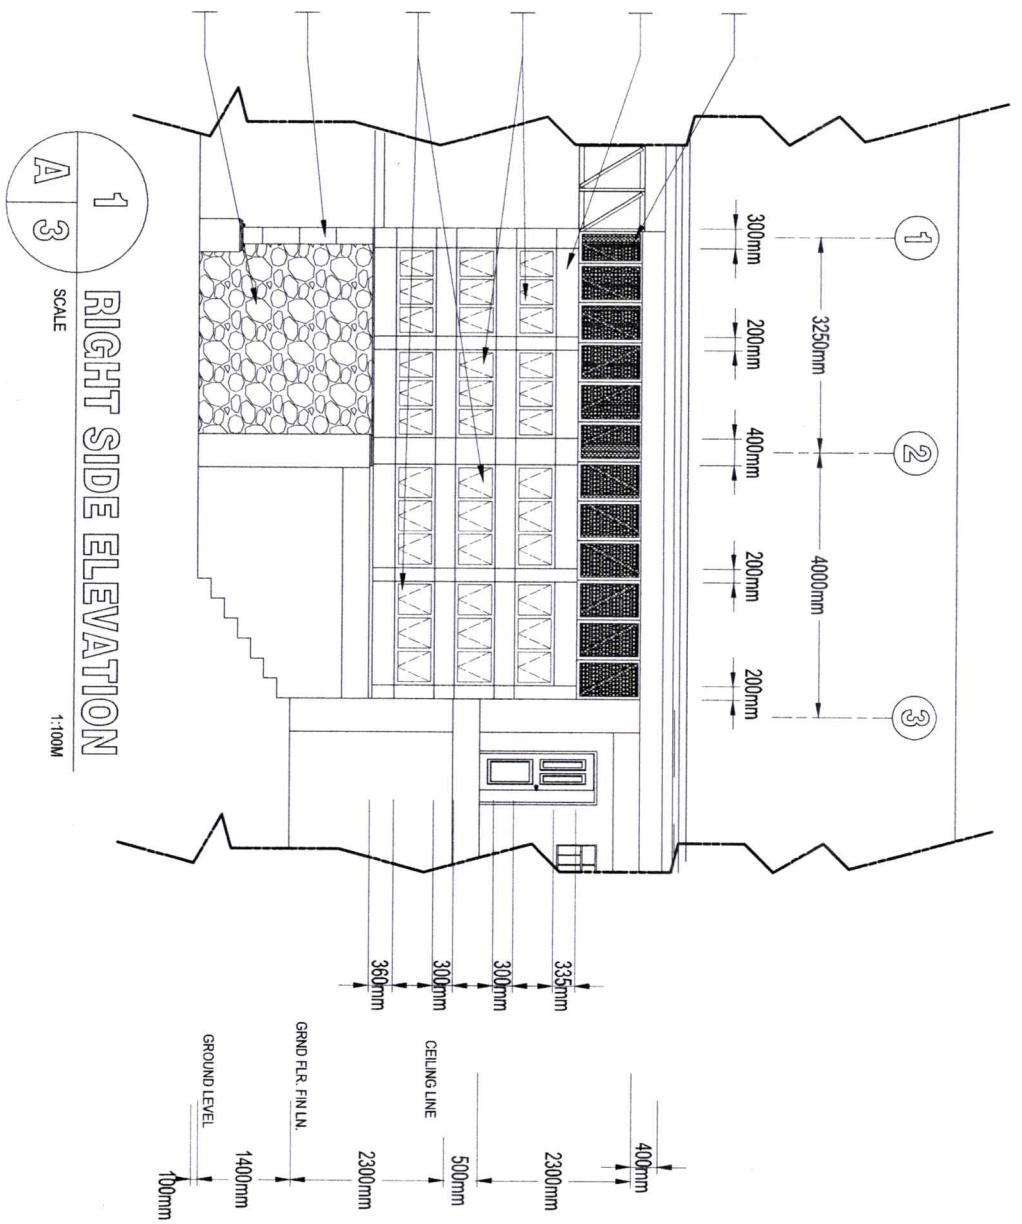

RIGHT SIDE ELEVATION
 SCALE 1:100M

PREPARED BY:
 CULLEN S. WEGYON
 DRAFTSMAN II
 Feb 2021


CHECKED AND REVIEWED:
 CHRISTOPHER B. HAOSAN
 ENGINEER III


RECOMMENDING APPROVAL:
 EDGAR H. MADLIANG
 CHIEF, ESSD

APPROVED BY:
 ESTELA L. CARINO
 REGIONAL DIRECTOR

PROJECT TITLE:
 REPAIR/ REHABILITATION OF VARIOUS OFFICES
 AT THE DEPED-CAR REGIONAL OFFICE
 LOCATION: WANGAL, LA TRINIDAD, BENGUET
 SHEET CONTENT: AS SHOWN

SHEET NO.:

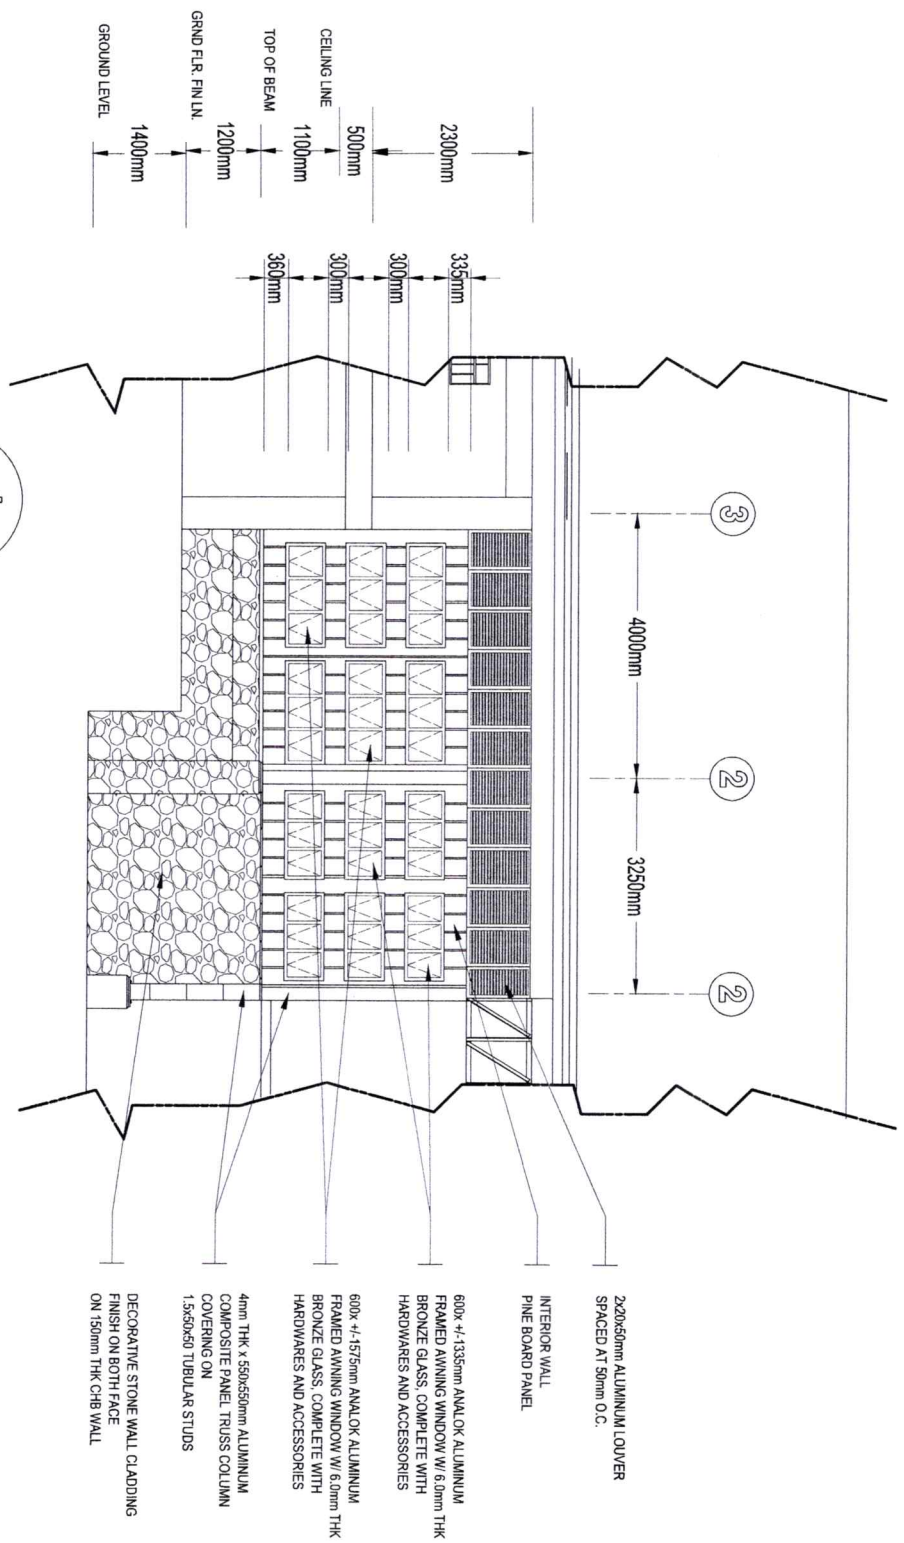

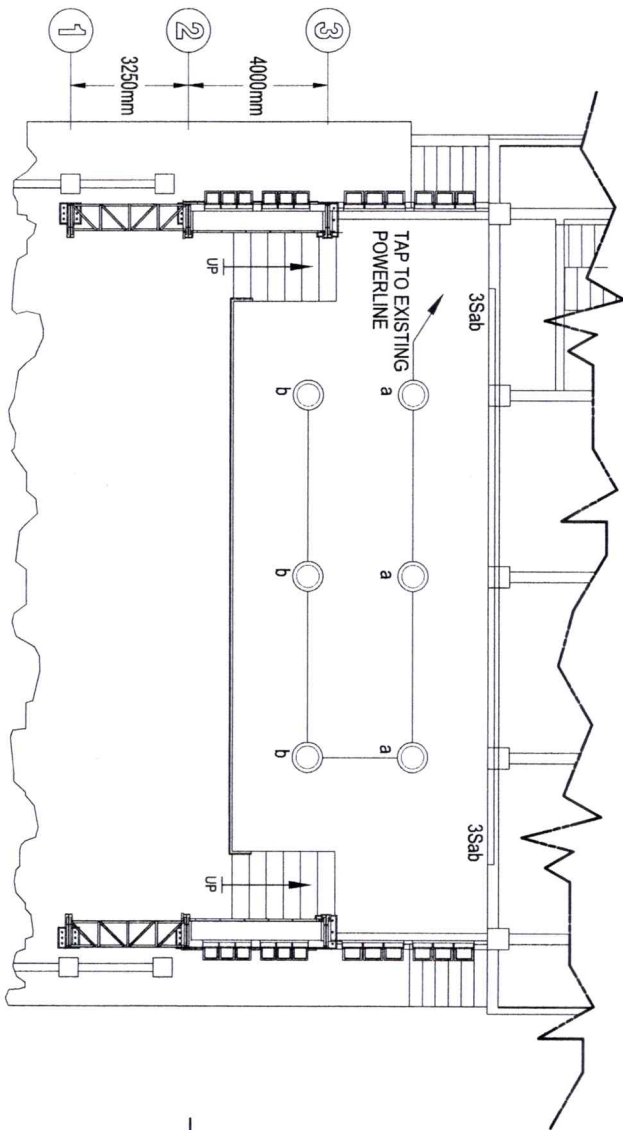

- HIGH BAY LED LIGHT
- THREE WAY SWITCH
- RACEWAY CONDUIT

1
E 5

LIGHTING LAYOUT
DRAWN
NTS

<p>REPUBLIC OF THE PHILIPPINES DepEd EDUCATION FACILITIES SECTION WANGAL, LA TRINIDAD, BENGUET</p>	PREPARED BY CULLEN S. WEGYON DRAFTSMAN II Feb 2021	CHECKED AND REVIEWED BY CHRISTOPHER B. HADSAN ENGINEER III	RECOMMENDING APPROVAL EDGAR H. MADLANO CHIEF ENGINEER	APPROVED BY ESTEL AL CARINO MANAGING ENGINEER	PROJECT TITLE: REPAIR/REHABILITATION OF VARIOUS OFFICES AT THE DEPED-CAR REGIONAL OFFICE WANGAL, LA TRINIDAD, BENGUET AS SHOWN	SHEET NO.: E 1 5
---	--	---	--	--	--	------------------------